


Scottish Borders Council  
Town And Country  
Planning (Scotland) Act  
1997

20/00343/FUL  
02.07.2020

**REFUSED**

subject to the  
requirements of the  
associated Decision  
Notice

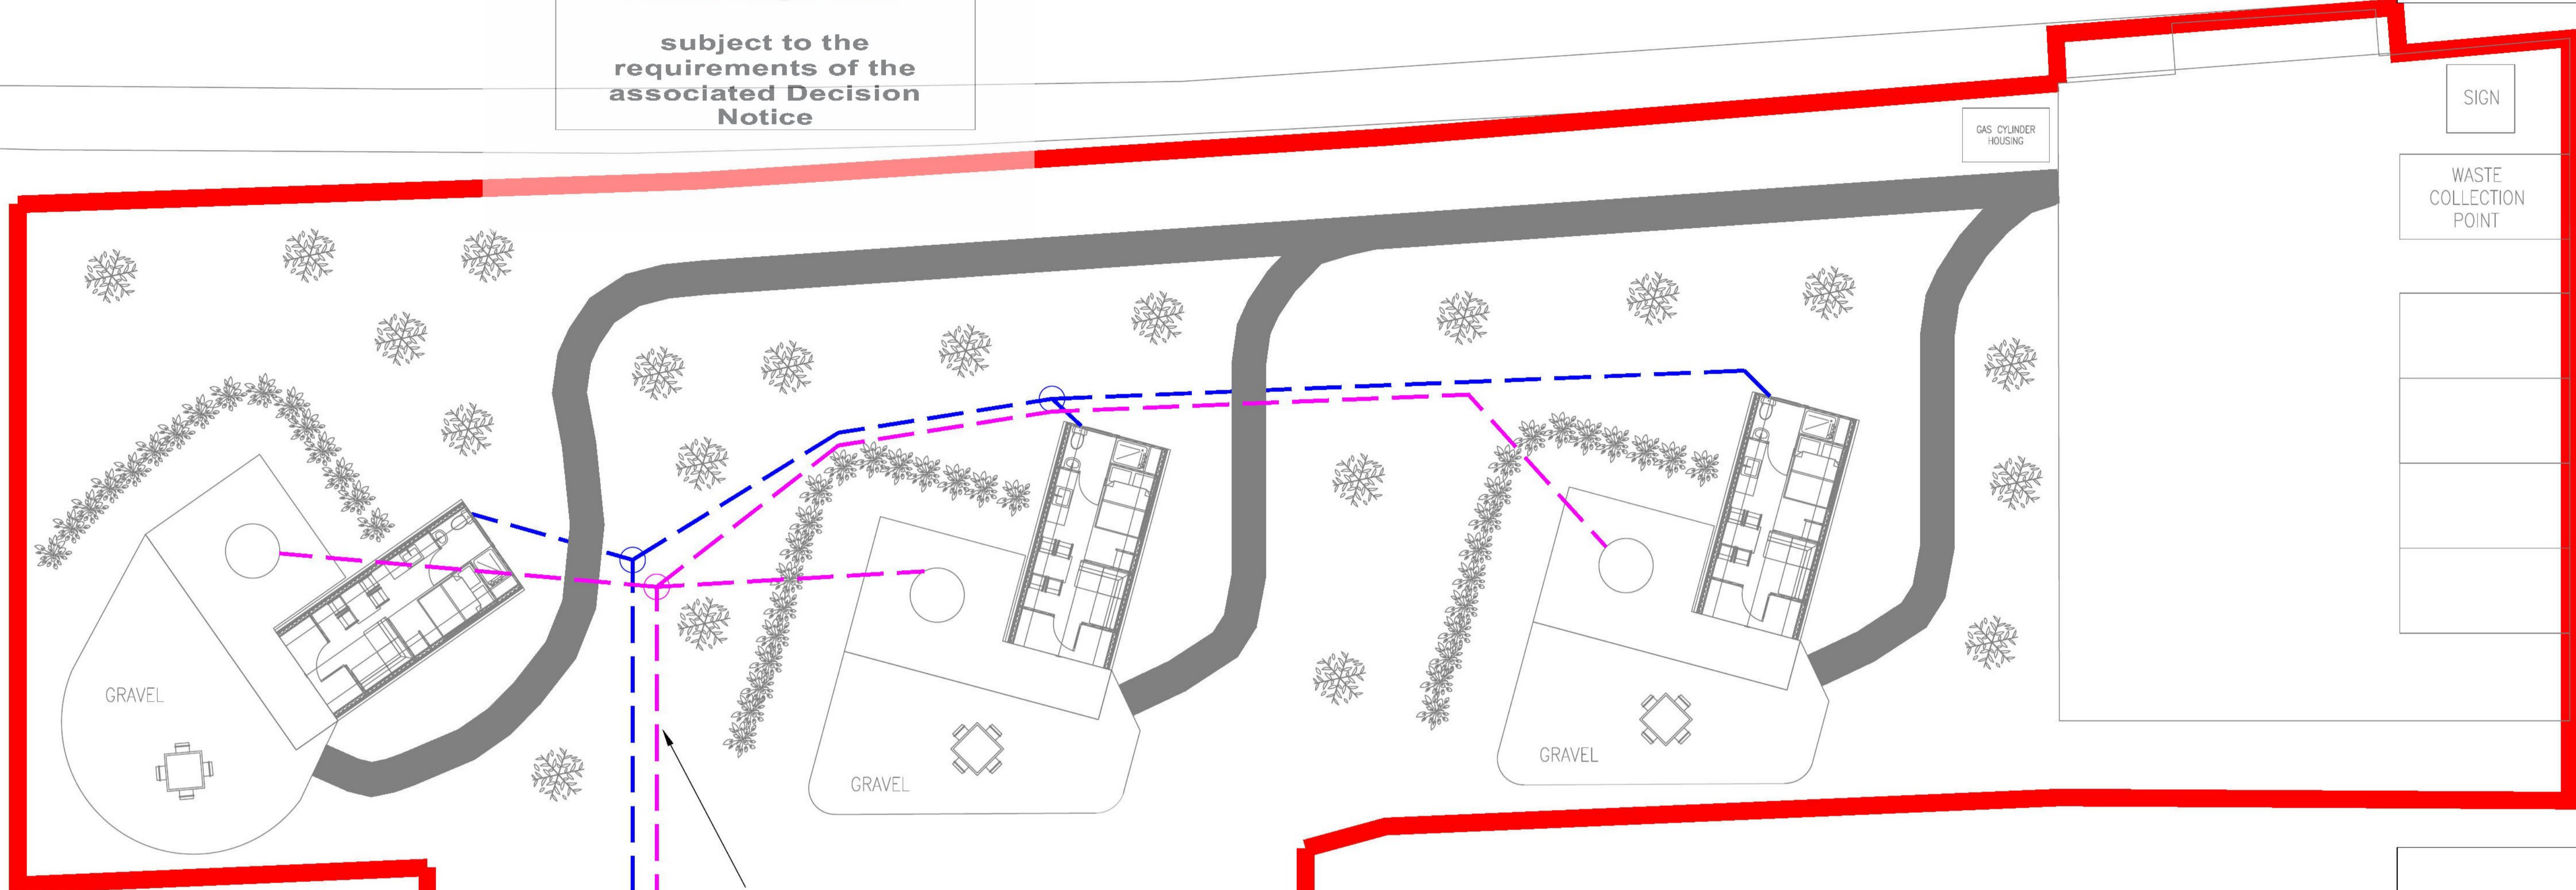

DRAINAGE LAYOUT (SCALE 1:100)

150mm dia. uPVC PIPEWORK ROUTE  
THROUGHOUT IN COMPLIANCE WITH BS EN  
12056-1:2000

750mm GRP INSPECTION CHAMBER IN  
COMPLIANCE WITH BS EN 12056-1:2000

12 PERSON TREATMENT PLANT IN LINE WITH  
WITH ALL SEPA STIPULATIONS AND BS EN  
12056-1:2000


UNDERGROUND SOAKAWAY FULLY COMPLIANT  
WITH ALL SEPA STIPULATIONS

$V_p = 29.6$



$AREA = V_p \times P_{ax} \times 0.25$

$AREA = 88.8m^2$

TOTAL SIZE = 9.5m X 9.5m

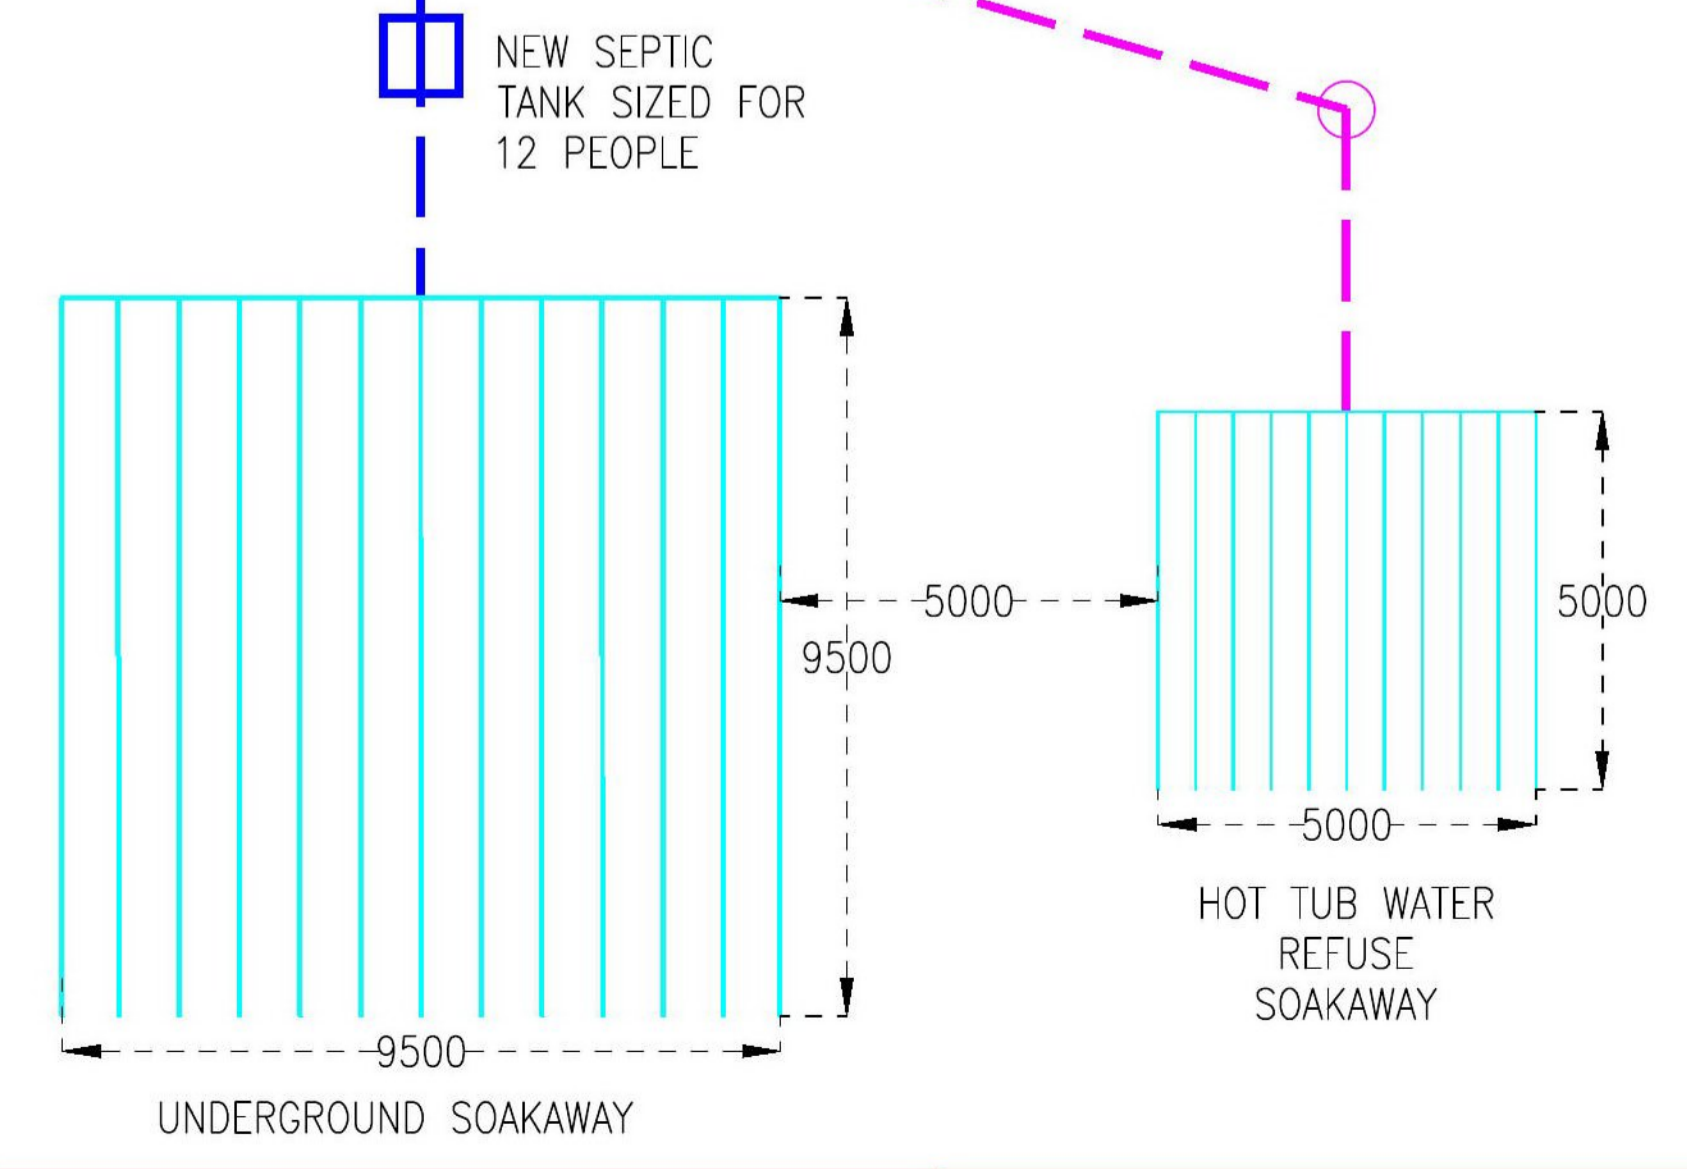


NOTES  
1. DO NOT SCALE FROM THIS DRAWING  
KEY TO SYMBOLS

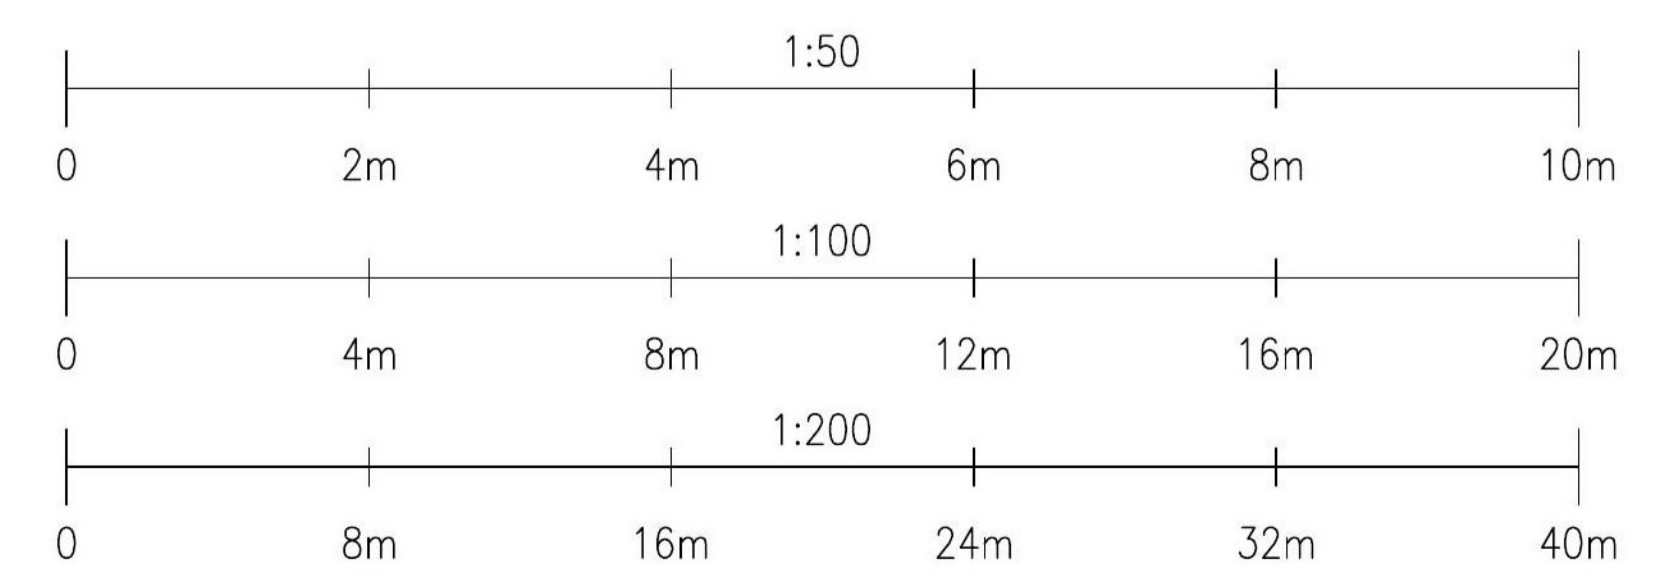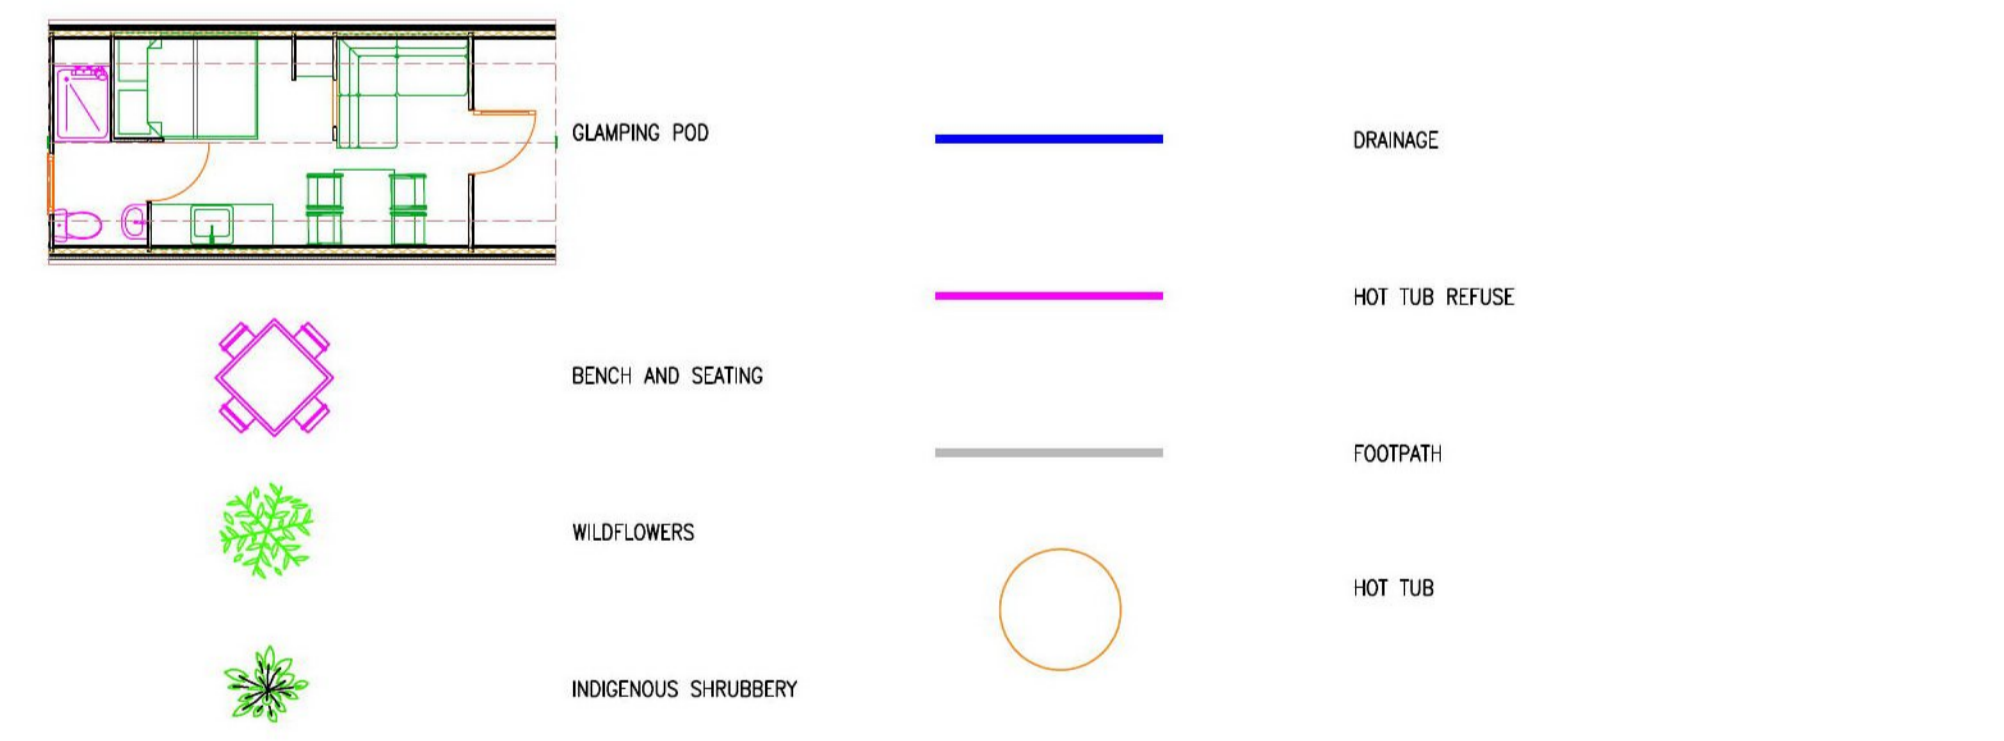

SCALE BARS

Date	Description	Rev	By
------	-------------	-----	----

Revision Description

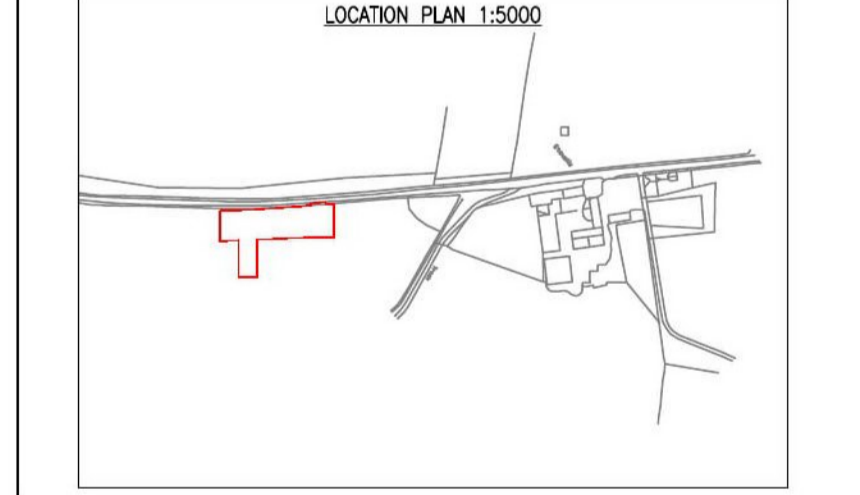

Project:  
**STOULIE SNUGS LUXURY GLAMPING PODS  
HAWICK  
TD9 7NX**

Drawing Title:  
**PROPOSED DRAINAGE PLAN**

Drawing Number:  
**200104-2-01**

Revision:  
Date: 14/03/2020

Scale: 1:100 (UNLESS STATED)  
Drawn By: CALUM MACLEOD

CAD Dwg File:  
Arch. Base Dwg:

Issue Status:  
**Full Planning Application**